


LAST SAVED BY: kbequette DATE: 05-DEC-2008 17:08 PROJECT NO. 7473A.10 FILE NAME: G-06.dgn


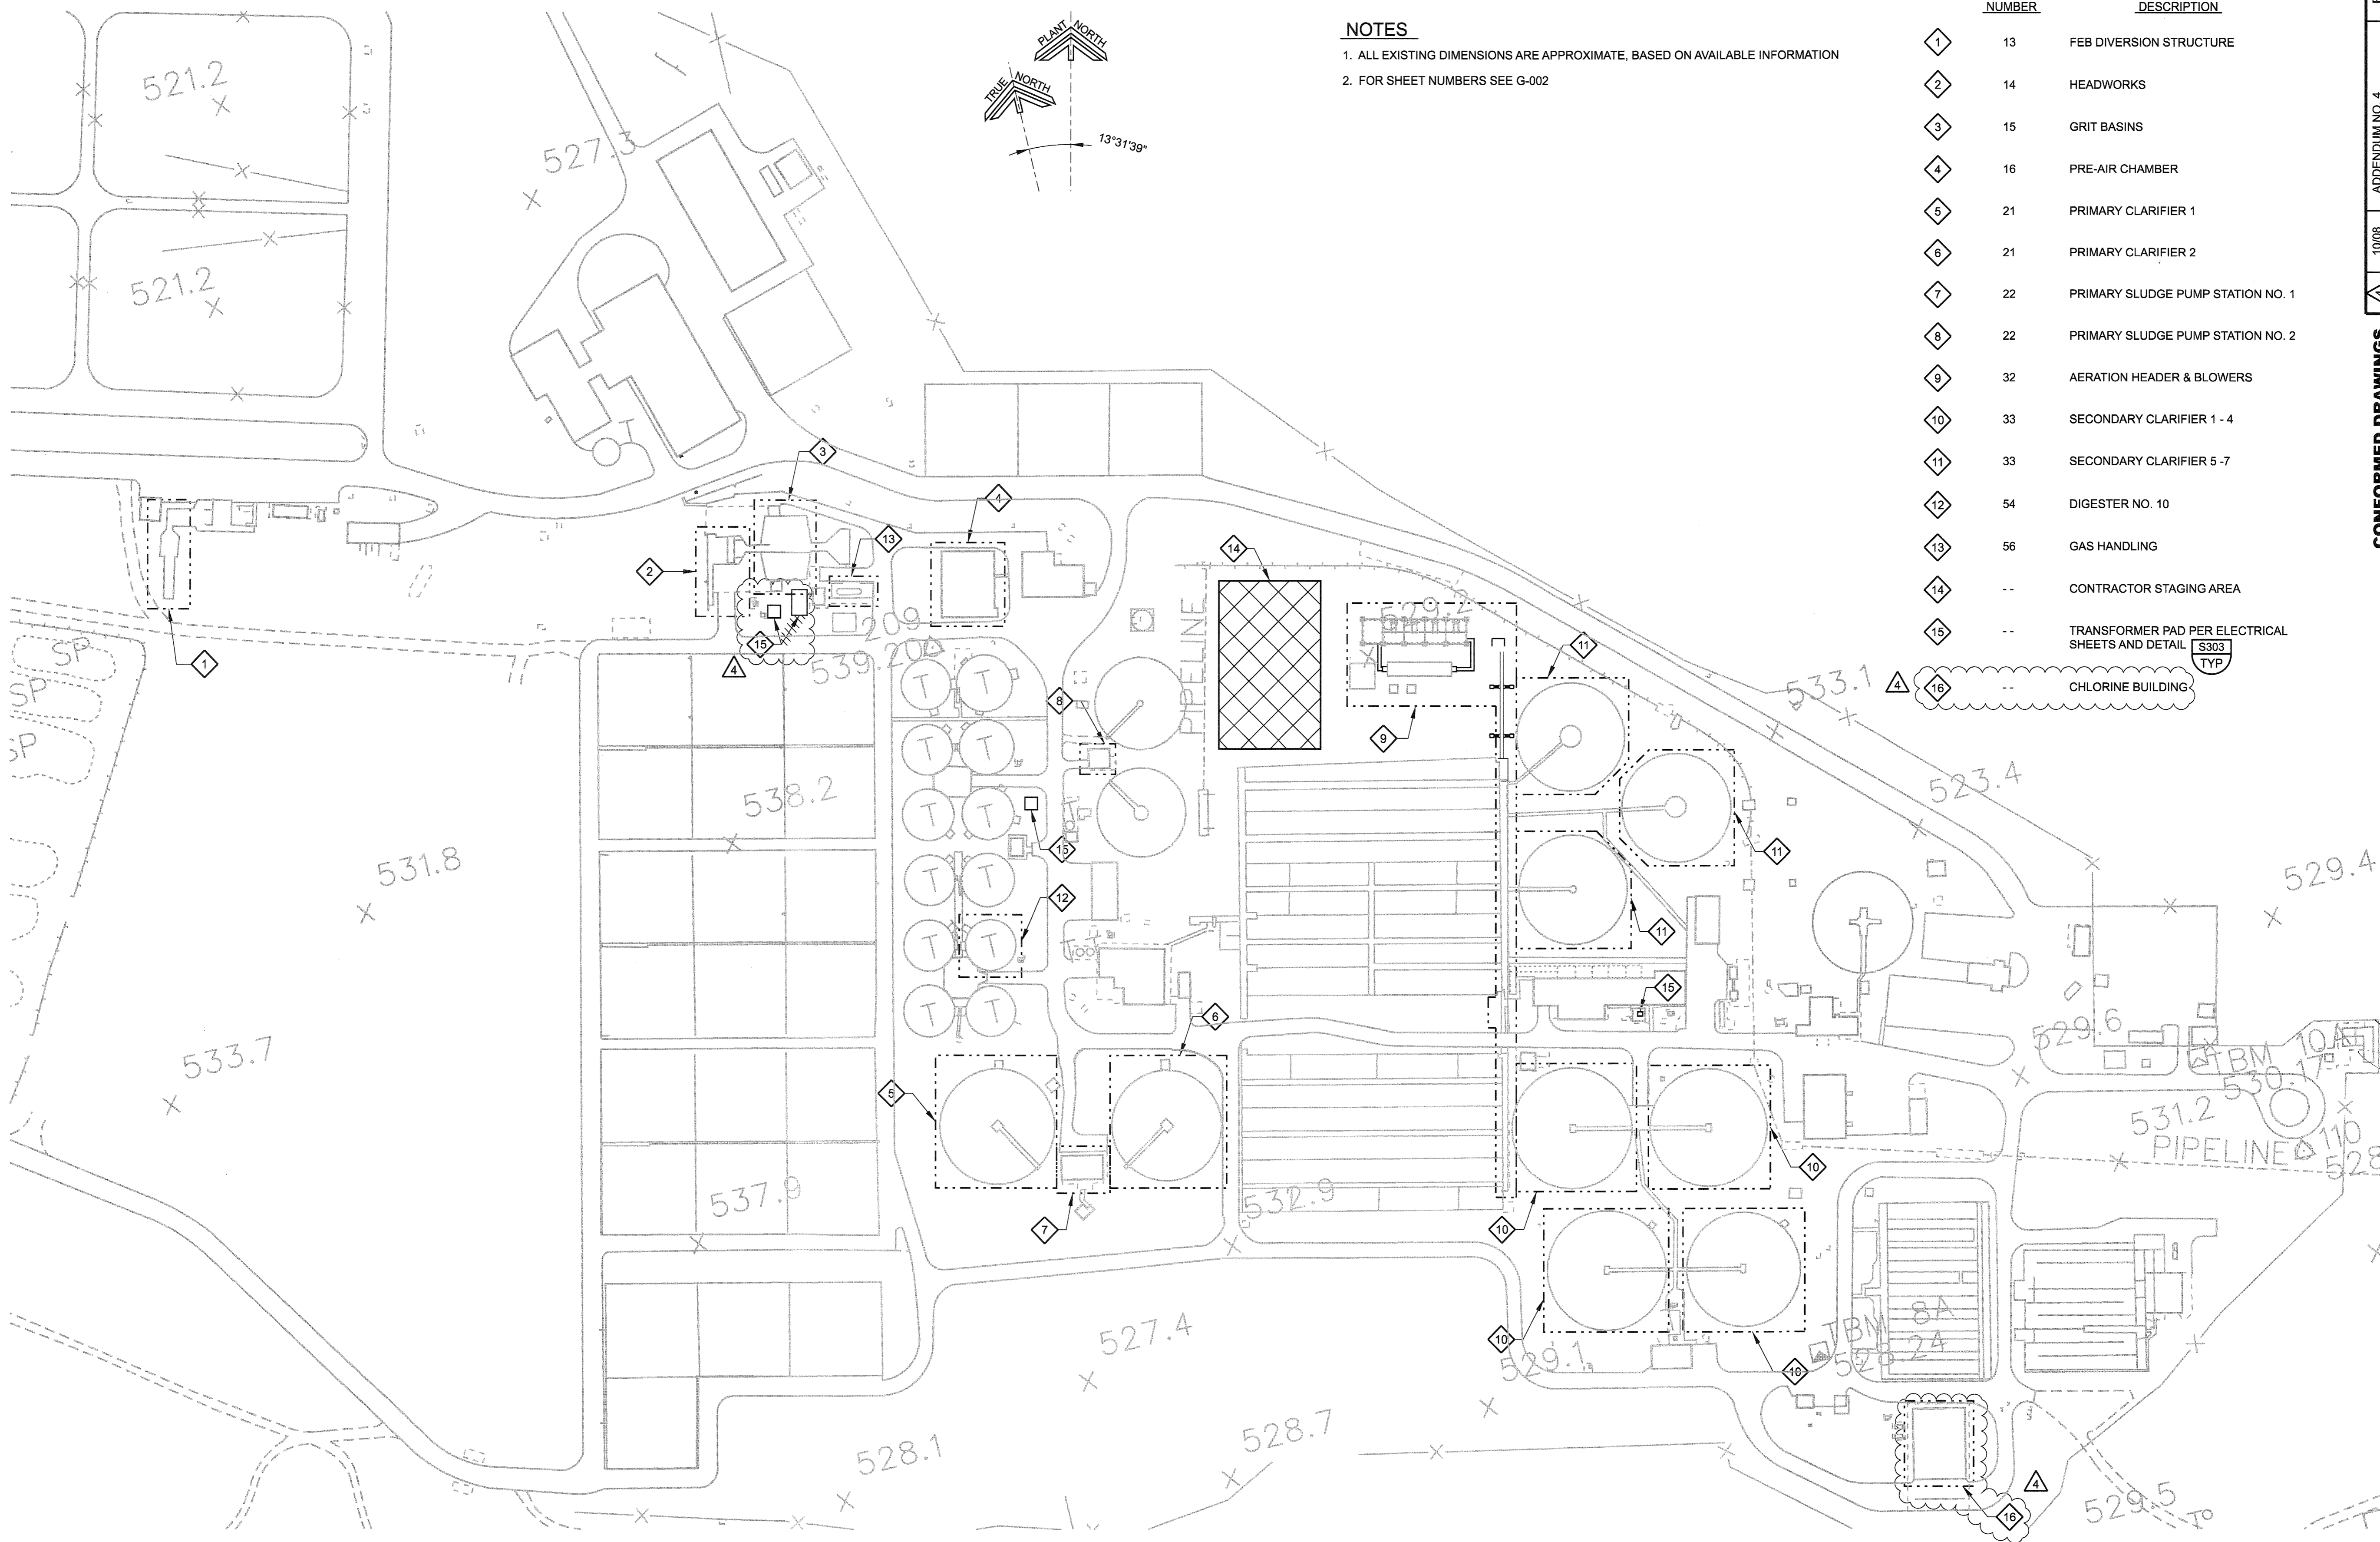


**NOTES**  
 1. ALL EXISTING DIMENSIONS ARE APPROXIMATE, BASED ON AVAILABLE INFORMATION  
 2. FOR SHEET NUMBERS SEE G-002

FACILITY NUMBER	DESCRIPTION
1	FEB DIVERSION STRUCTURE
2	HEADWORKS
3	GRIT BASINS
4	PRE-AIR CHAMBER
5	PRIMARY CLARIFIER 1
6	PRIMARY CLARIFIER 2
7	PRIMARY SLUDGE PUMP STATION NO. 1
8	PRIMARY SLUDGE PUMP STATION NO. 2
9	AERATION HEADER & BLOWERS
10	SECONDARY CLARIFIER 1 - 4
11	SECONDARY CLARIFIER 5 - 7
12	DIGESTER NO. 10
13	GAS HANDLING
14	CONTRACTOR STAGING AREA
15	TRANSFORMER PAD PER ELECTRICAL SHEETS AND DETAIL S303 TYP
16	CHLORINE BUILDING

REK	APP.
ADDENDUM NO. 4	REVISIONS
10/08	DATE
4	No.

**CONFORMED DRAWINGS**

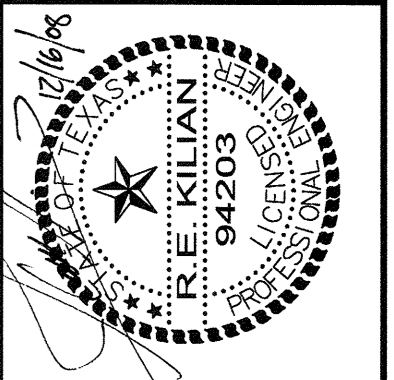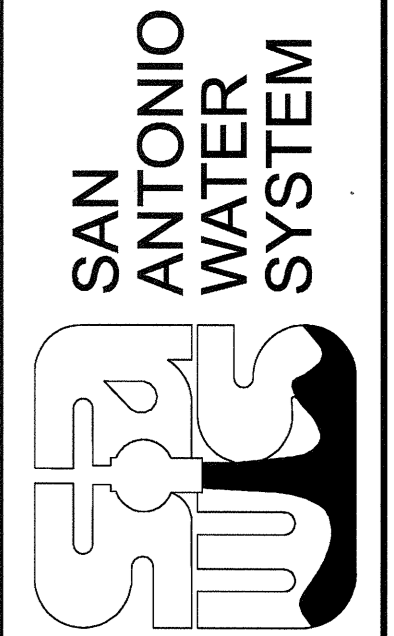

SAWS JOB No. 06-6502  
 LEON CREEK WRC  
 IMPROVEMENTS PROJECT  
 GENERAL  
**SITE PLAN**

Designed by:  
 Drawn by: DE  
 Checked by:  
 Drawing **00G06**  
 Sheet 6 of 472

CONTRACT DOCUMENTS DATED JULY 2008, AS PART OF THE BIDDING DOCUMENTS (DRAWINGS AND SPECIFICATIONS) AND SUBSEQUENTLY ISSUED ADDENDA HAVE BEEN MERGED INTO ONE CONFORMING SET OF DOCUMENTS FOR THE CONVENIENCE OF THE CONTRACTOR. THE "CONFORMED" DOCUMENTS ARE FOR REFERENCE ONLY AND ARE NOT CONTRACT DRAWINGS. IF INCONSISTENCIES OR AMBIGUITIES BETWEEN "CONFORMED" DOCUMENTS AND CONTRACT DOCUMENTS ARE FOUND, THE CONTRACT DOCUMENTS SHALL GOVERN.